
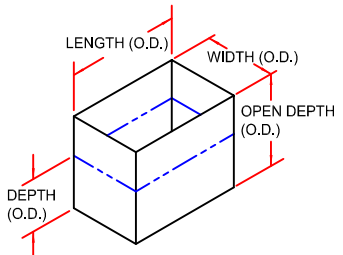


**PLAN VIEW**

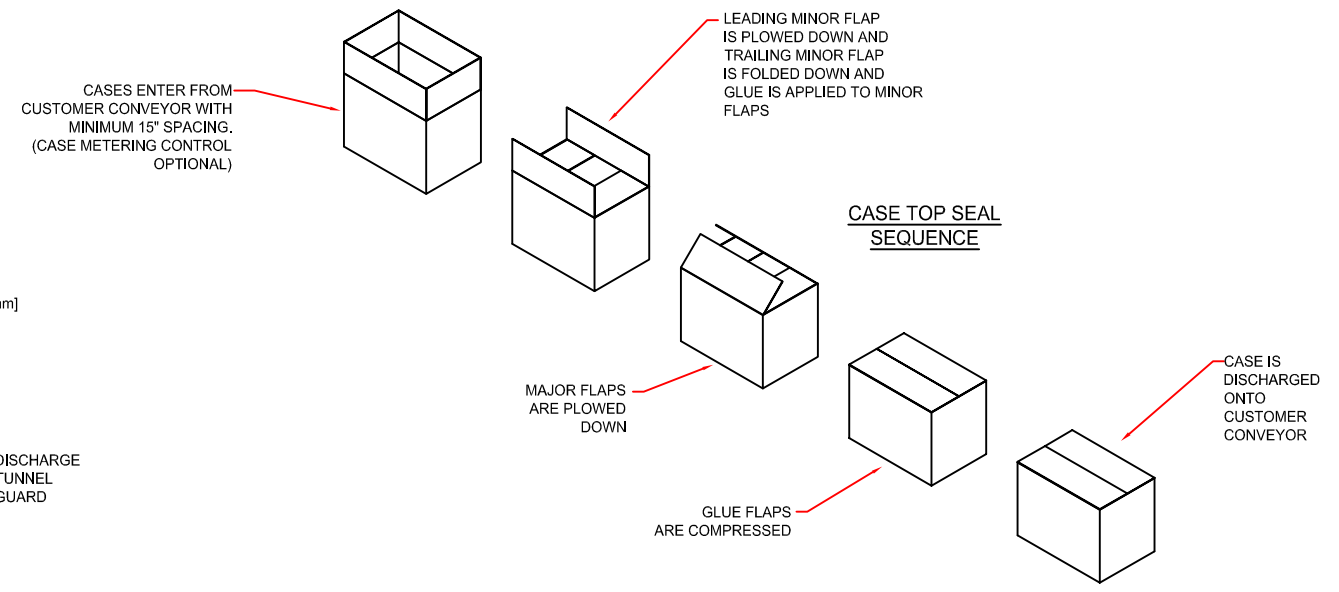


**SET-UP CASE**

**STANDARD ERECTED CASE SIZE**

CASE	LENGTH	WIDTH	DEPTH	OPEN DEPTH
MINIMUM	8.0\"(204)	5.0\"(127)	4.75\"(121)	7.0\"(178)
MAXIMUM	24.0\"(610)	16.0\"(407)	18.5\"(470)	22.75\"(578)

SEE ORDER SPECIFICATION DOCUMENT FOR SPECIFIC CUSTOMER CASE SIZES

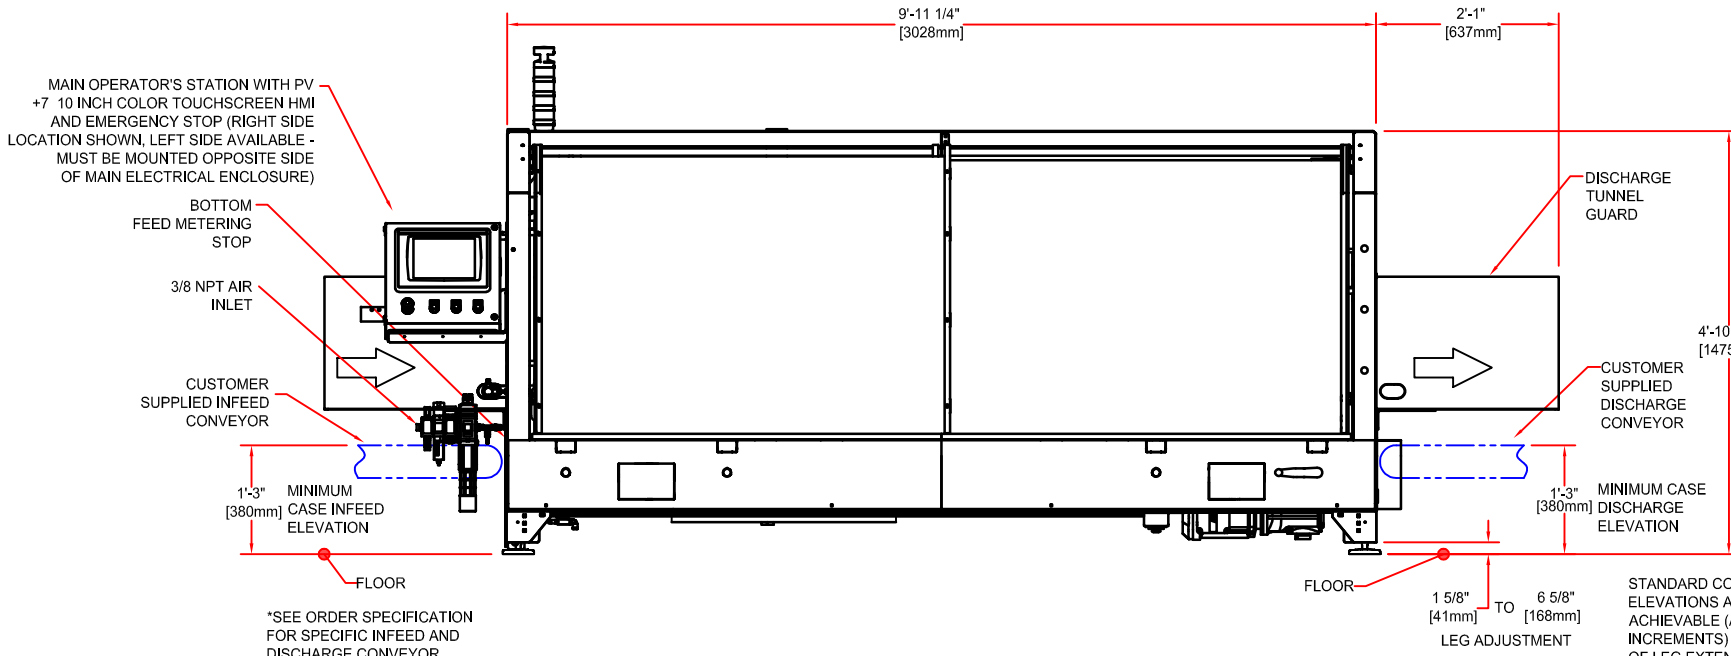

**ELEVATION VIEW**

**UTILITY REQUIREMENTS**

AIR REQUIREMENTS: 0.100 SCF/CYCLE @ 80PSI (0.003m<sup>3</sup>/CYCLE @ 551.2KPa)  
 ELECTRICAL REQUIREMENTS: 460 V/3 PHASE/60 Hz STANDARD  
 FULL LOAD AMPS - 25.2 AMPS  
 DISCONNECT SIZE - 30 AMP

**NOTE: UTILITIES INFO LISTED IS PRELIMINARY AND IS SUBJECT TO CHANGE WITH FINAL DESIGN**

MACHINE WEIGHT (APPROXIMATE): 650 Kg (1434 LBS.)  
 MACHINE SPEED: SEE ORDER SPECIFICATION FOR MACHINE SPEED

STANDARD CONVEYOR ELEVATIONS ARE 15\"/>

DATE	REVISION	REV. NO.	REV. BY	CHKD BY
12/21/20	UPDATED MACHINE FLA		ADT	
6/4/20	UP-DATE MACHINE PER 30 DAY LEAD TIME CHANGES		K.A.	
1/29/19	ADD DISCHARGE TUNNEL GUARD AS STANDARD		K.A.	
3/25/18	PV 1000 WAS PV700, UP-DATE ELECT UTILITY INFO		K.A.	
11/29/17	ADD OPTIONAL CONFIGURATION TEXT	-4	K.A.	
9/9/16	CHANGE CLOSED DEPTH FROM 4.5\"/>			
7/13/15	UP-DATE TO NEW MODEL NUMBER		K.A.	
3/17/15	ENCLOSURE IS NOW 12\"/>			
6/4/14	PV +6 7 INCH HMI WAS PV 400, SHOW OPT METERING INF STOP & TUNNEL GRD		K.A.	
1/21/09	SHOWN LAYOUT PER LAYERED FLOOR PLAN		K.A.	
8/8/08	SHOW INFEED CONV PHANTOMED & OPTIONAL		K.A.	
6/2/08	SHOW 36X36 ENCLOSURE (WAS 30X30)		K.A.	
5/19/08	CORRECTED LEG ADJUST AND INFEED/DISCHARGE ELEV		K.A.	

PROPRIETARY  
 NEITHER THIS DOCUMENT NOR THE INFORMATION CONTAINED THEREIN MAY BE REPRODUCED OR DISCLOSED TO ANYONE WITHOUT THE WRITTEN PERMISSION OF R.A. PEARSON CO.

2' - 2 7/16"  
 672  
 DIMENSIONS ARE IN FOOT FRACTION INCH OVER MILLIMETERS.

**PEARSON**  
 PACKAGING SYSTEMS  
 8125 WEST SUNSET HIGHWAY  
 SPOKANE, WASHINGTON 99224  
 WWW.PEARSONPKG.COM

TITLE  
**CS40-67G CASE SEALER**

DR. [ ]  
 CHK. [ ]  
 APP. [ ]

DWG NO.  
**D590394-4**

SCALE N/A SHEET 1 OF 1